



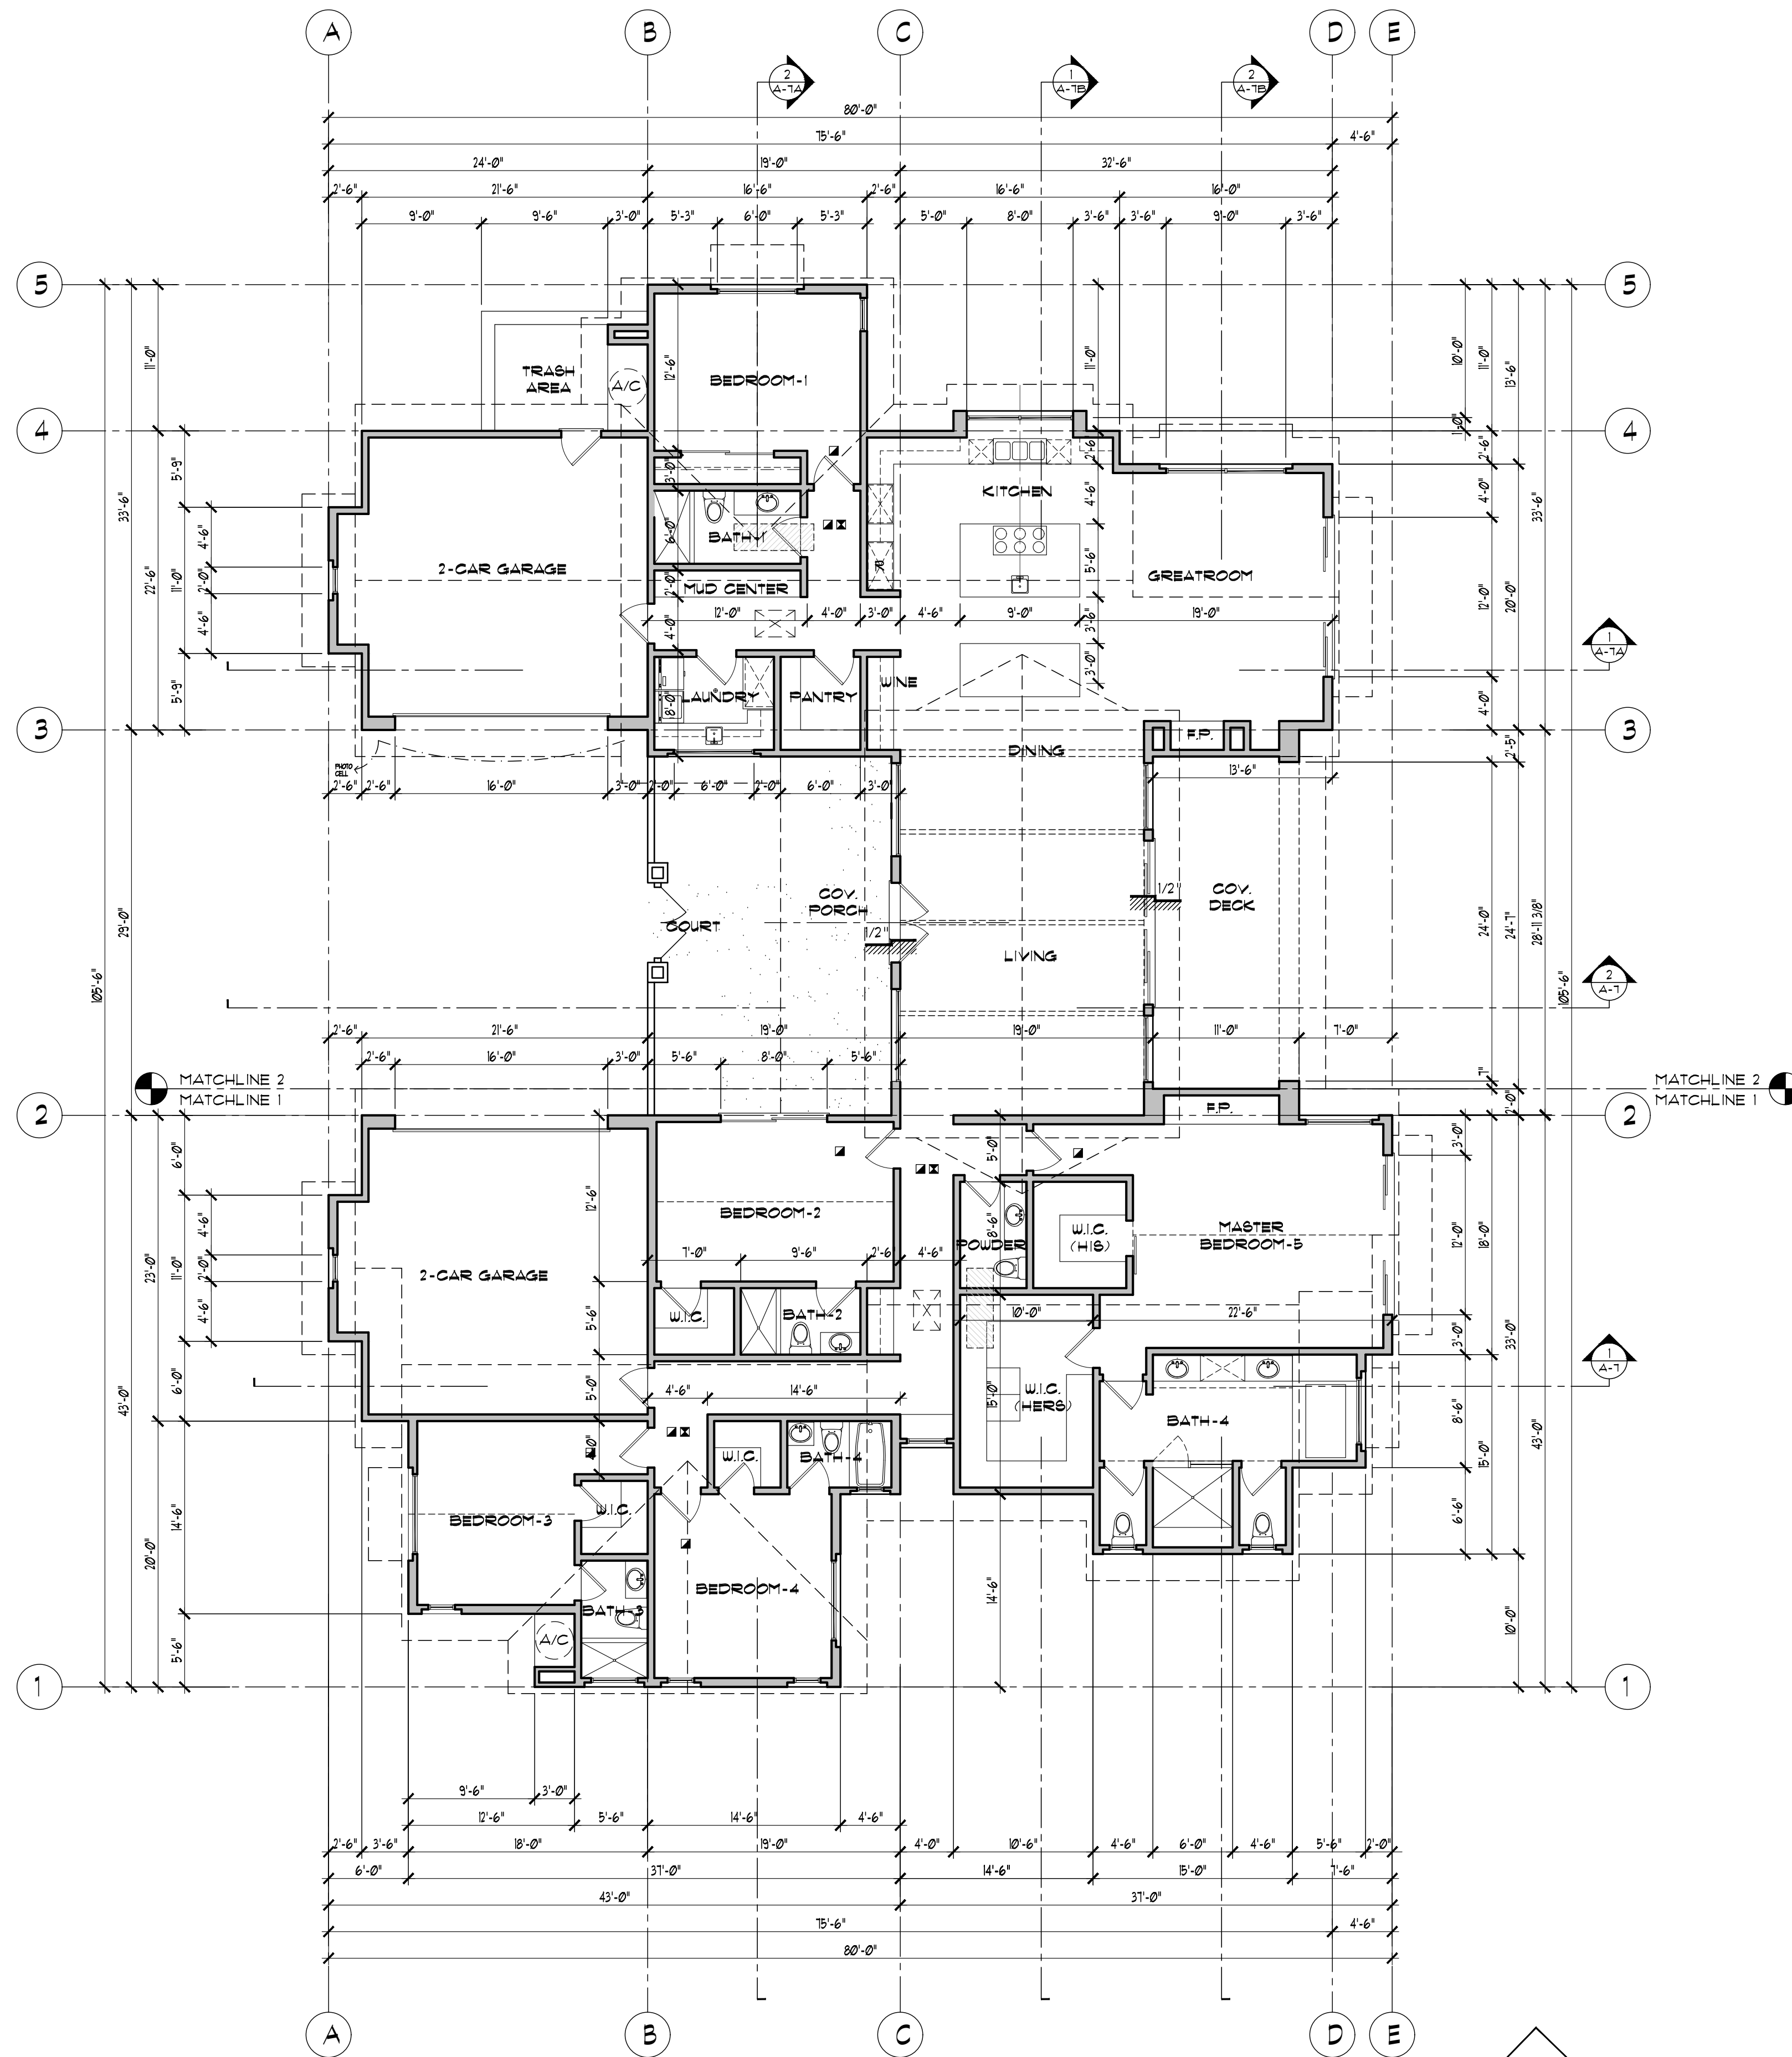

- NOTES:
1. PROVIDE PANEL CAPACITY AND CONDUIT FOR THE FUTURE INSTALLATION OF A 208/240V 40AMP, GROUNDED AC OUTLET FOR EACH DWELLING UNIT.
 2. BATHROOM EXHAUST FANS SHALL BE ENERGY STAR COMPLIANT AND BE DUCTED TO TERMINATE TO THE OUTSIDE OF THE BUILDING. (4506.1)
 3. BATHROOM EXHAUST FANS, NOT FUNCTIONING AS A COMPONENT OF A WHOLE HOUSE VENTILATION SYSTEM, MUST BE CONTROLLED BY A HUMIDISTAT WHICH SHALL BE READILY ACCESSIBLE. (4506.1)

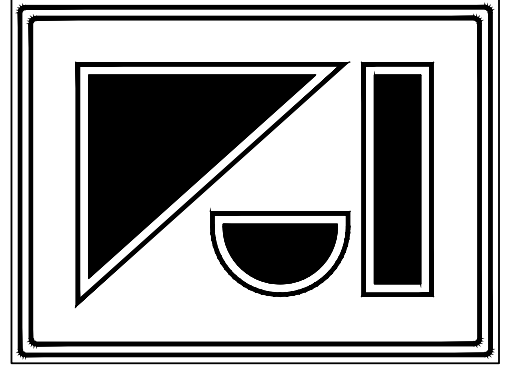

**VALENTINE JANEV
ARCHITECT, INC.**

B.A., B. ARCH., M.A.I.B.C., M.R.A.I.C., A.I.A.
ARCHITECTURE
PLANNING
CONSTRUCTION MANAGEMENT
19261 Wells Drive,
Tarzana, Ca 91356

Phone (818) 222-0601

PROJECT:
**ISING SUN DRIVE
CUSTOM RESIDENCE**

10674 E. ISING SUN DR.,
SCOTTSDALE, AZ. 85262

OWNER:
-

SHEET TITLE:
FLOOR PLAN

THESE DRAWINGS AND SPECIFICATIONS ARE THE PROPERTY AND COPYRIGHT OF VALENTINE JANEV, ARCHITECT INC. AND SHALL NOT BE USED FOR ANY OTHER PURPOSE. LOCATION OR PARTY, AND MAY NOT BE REPRODUCED OR DISCLOSED TO OTHERS WITHOUT THE PRIOR WRITTEN CONSENT OF VALENTINE JANEV, ARCHITECT, INC. WRITTEN DIMENSIONS SHALL TAKE PRECEDENCE OVER SCALED DIMENSIONS AND SHALL BE VERIFIED AT THE JOB SITE. ANY DISCREPANCY SHALL BE BROUGHT TO THE ATTENTION OF VALENTINE JANEV, ARCHITECT, INC. PRIOR TO THE COMMENCEMENT OF ANY WORK.

VOID WITHOUT SIGNATURE AND SEAL

PRE-CONSTRUCTION		CONSTRUCTION		
ISSUED FOR	DATE	REV.	SUBJECT	DATE

DRAWN:
CHECKED:
DATE:
SCALE:
JOB NO:

SHEET NUMBER:

A-4

FLOOR PLAN

4,000 SQ. FT. LIVING
980 SQ. FT. GARAGES

1/8" = 1'-0"

